

[illegible]

ARTIS SENIOR LIVING OF BRIARCLIFF

BRIARCLIFF MANOR, NY

Dennis D. Smith, AIA Architect



Penniss D. Smith, AIA Architect ©
45 Riverview Wichita, KS 67203
316.268.0230 F 316.268.0205

CONTACT: DAN DOKKEN

DRAWN: SM, JW SB

PROJECT NUMBER:
14690


SHEET TITLE:
SITE LIGHTING PLAN

SHEET NUMBER:
SL1.1


1

STATISTICS					
DESCRIPTION	AVERAGE	MAXIMUM	MINIMUM	MAX/MIN	AVG/MIN
PARKING LOT	3.36 FC	8.5 FC	0.1 FC	85	33.6
PROPERTY LINE	0.8 FC	0.7 FC	0.0 FC	N/A	N/A
FRONT SIDEWALK	1.51 FC	2.8 FC	0.3 FC	9.33	5.03
REAR SIDEWALK	0.80 FC	3.6 FC	0.1 FC	N/A	N/A


FIXTURE TYPE(S)						
SYMBOL	MFR	CATALOG NUMBER	LAMP	LUMENS	LLF	MTG HEIGHT
R1	SPAULDING	CL1-A-30L-U-4K-3-BZ-8C	LED	5132	.9	14"-0" POLE
R2	SPAULDING	CL1-A-30L-U-4K-4-BZ-8C	LED	6318	.9	14"-0" POLE
K1	PROGRESS	PB03-AC-12NB-25-3K	LED	1116	.9	42" AFF
T	HYRELE	M4534-18TRT-348-BZ	CF180D/E/827	2040	.69	5" AFF
T1	STONCO	LPF2-E-4K-FL-K-F1-8-BZ	LED	3460	.69	AT GRADE, PEDISTAL

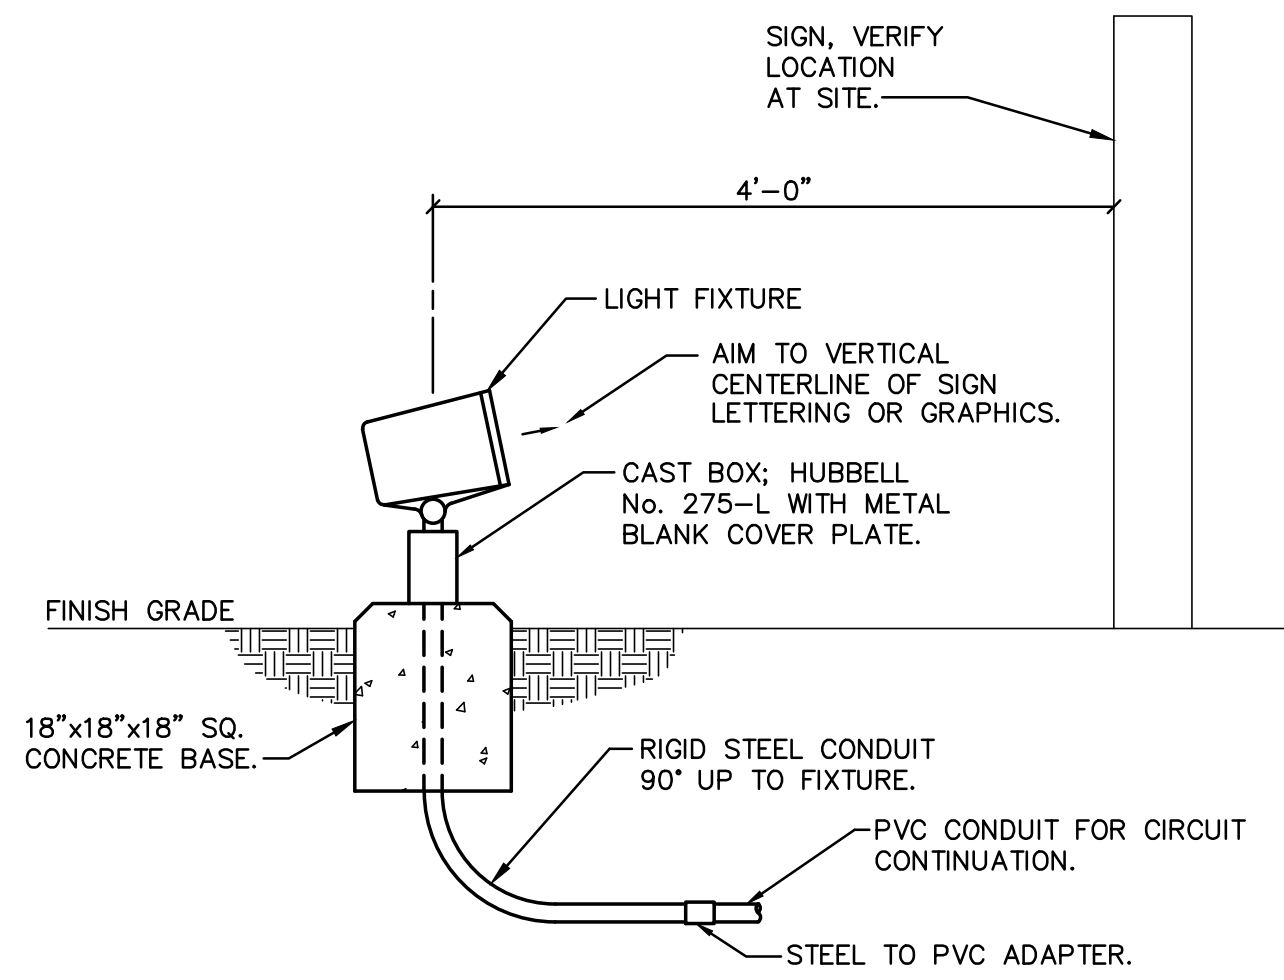


E **FIXTURE TYPE 'T1'**
MOUNTING DETAIL
N.T.S.

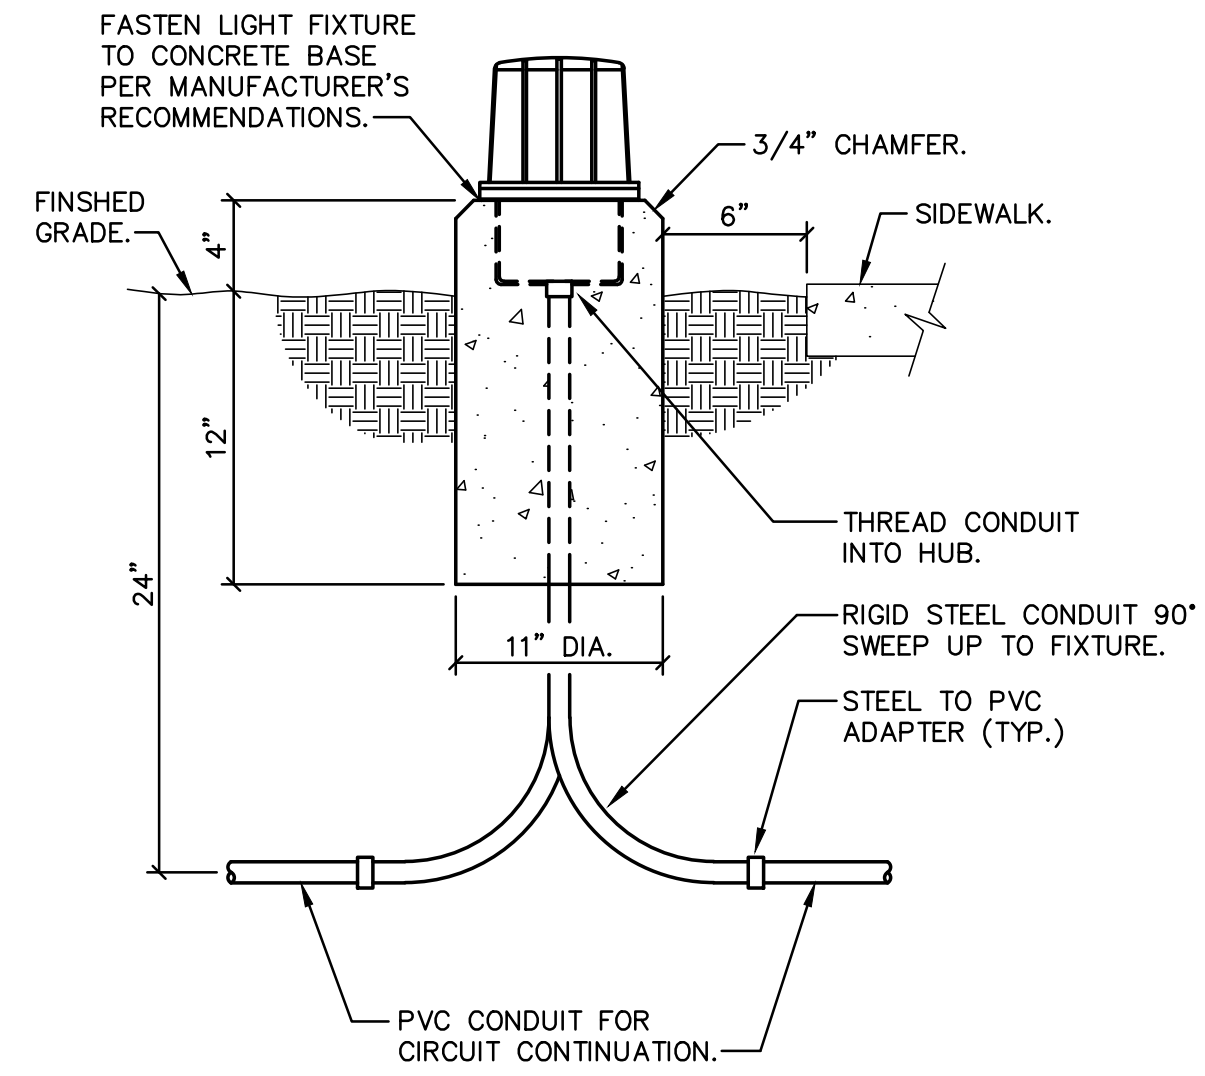


D FIXTURE TYPE 'T' MOUNTING DETAIL

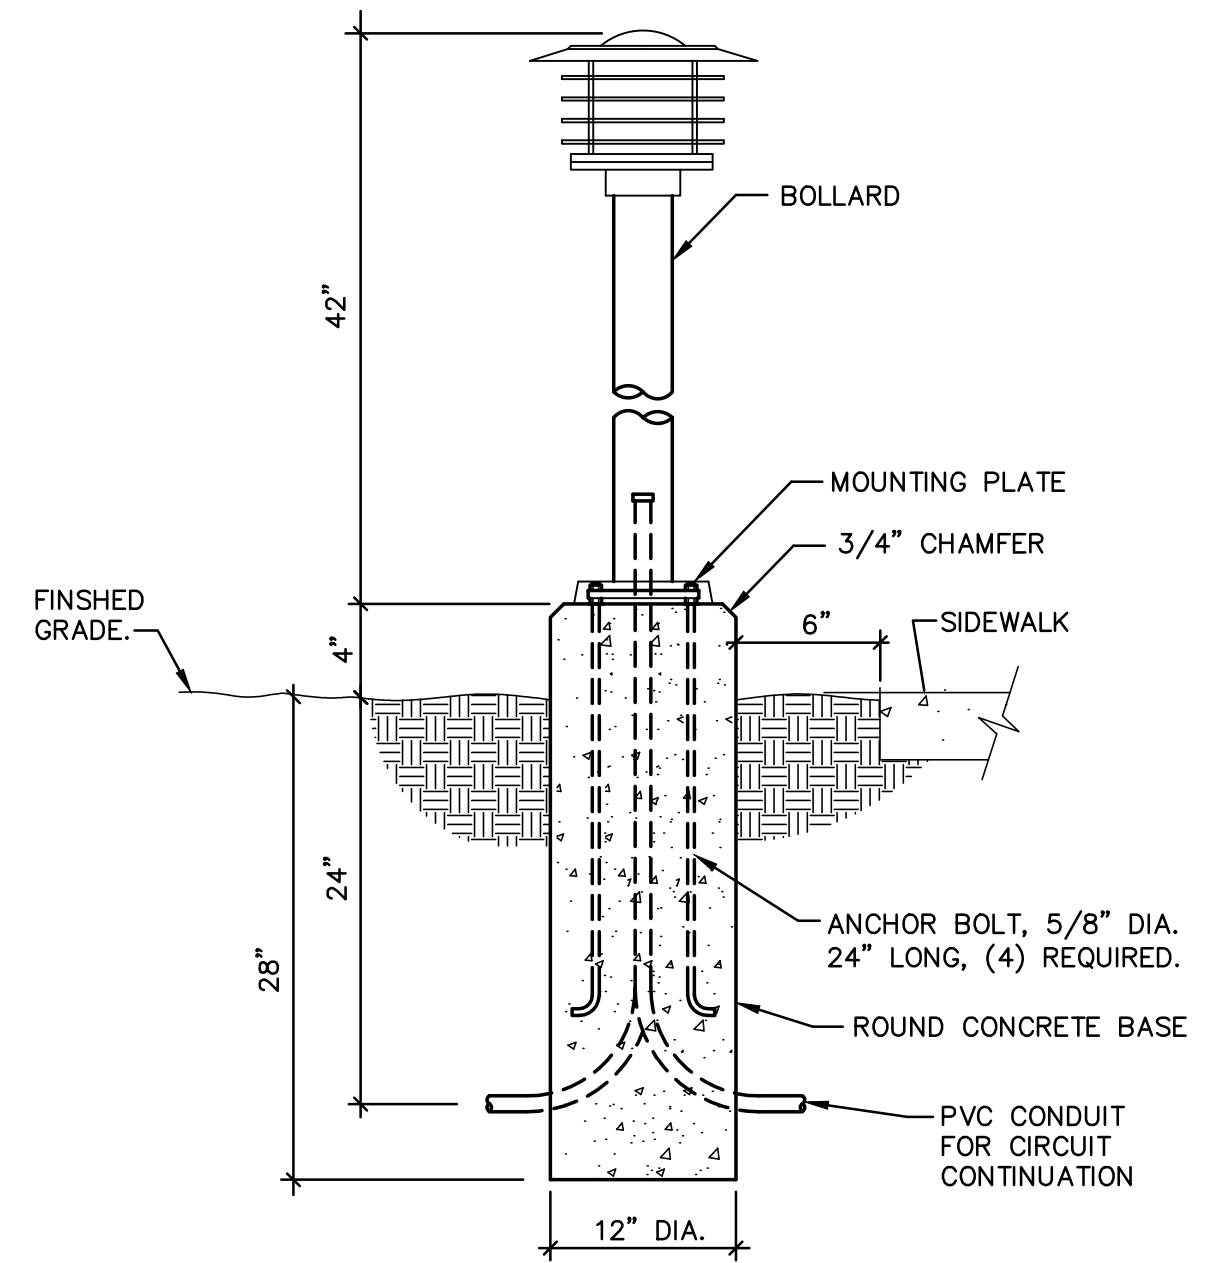

C **FIXTURE TYPE 'K1'**
MOUNTING DETAIL
N.T.S.

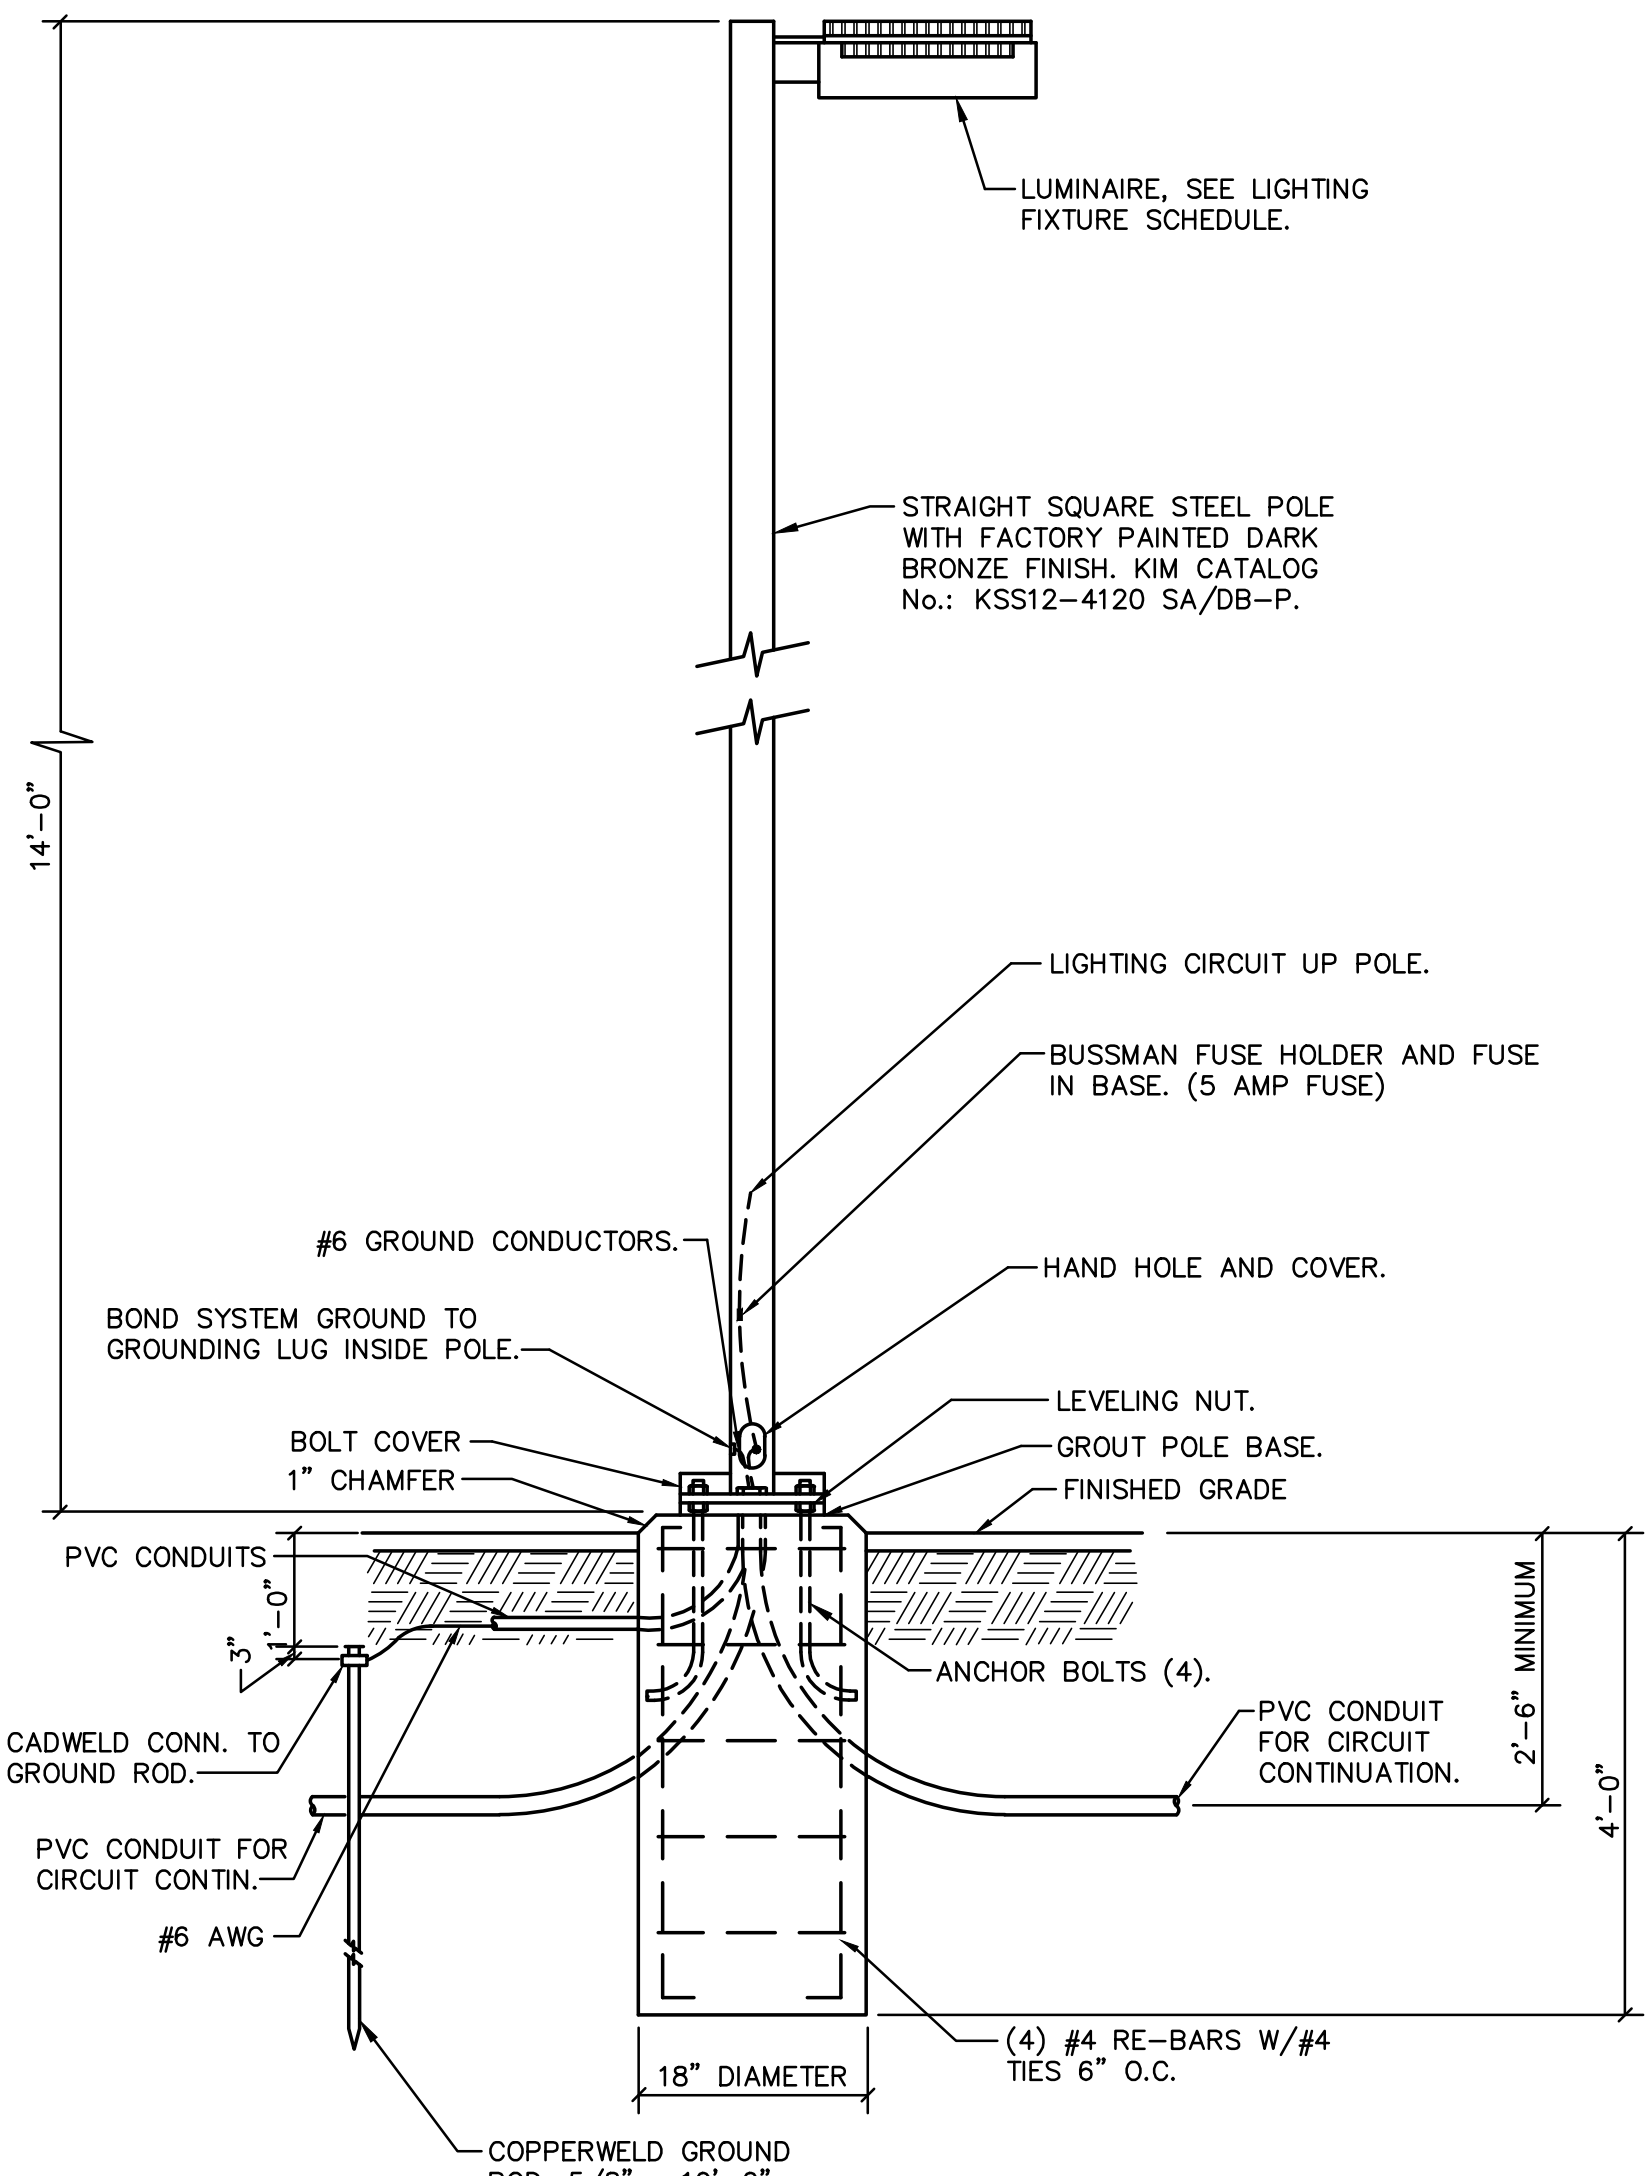

B FIXTURE TYPE 'R1' & 'R2' MOUNTING DETAIL
N.T.S.

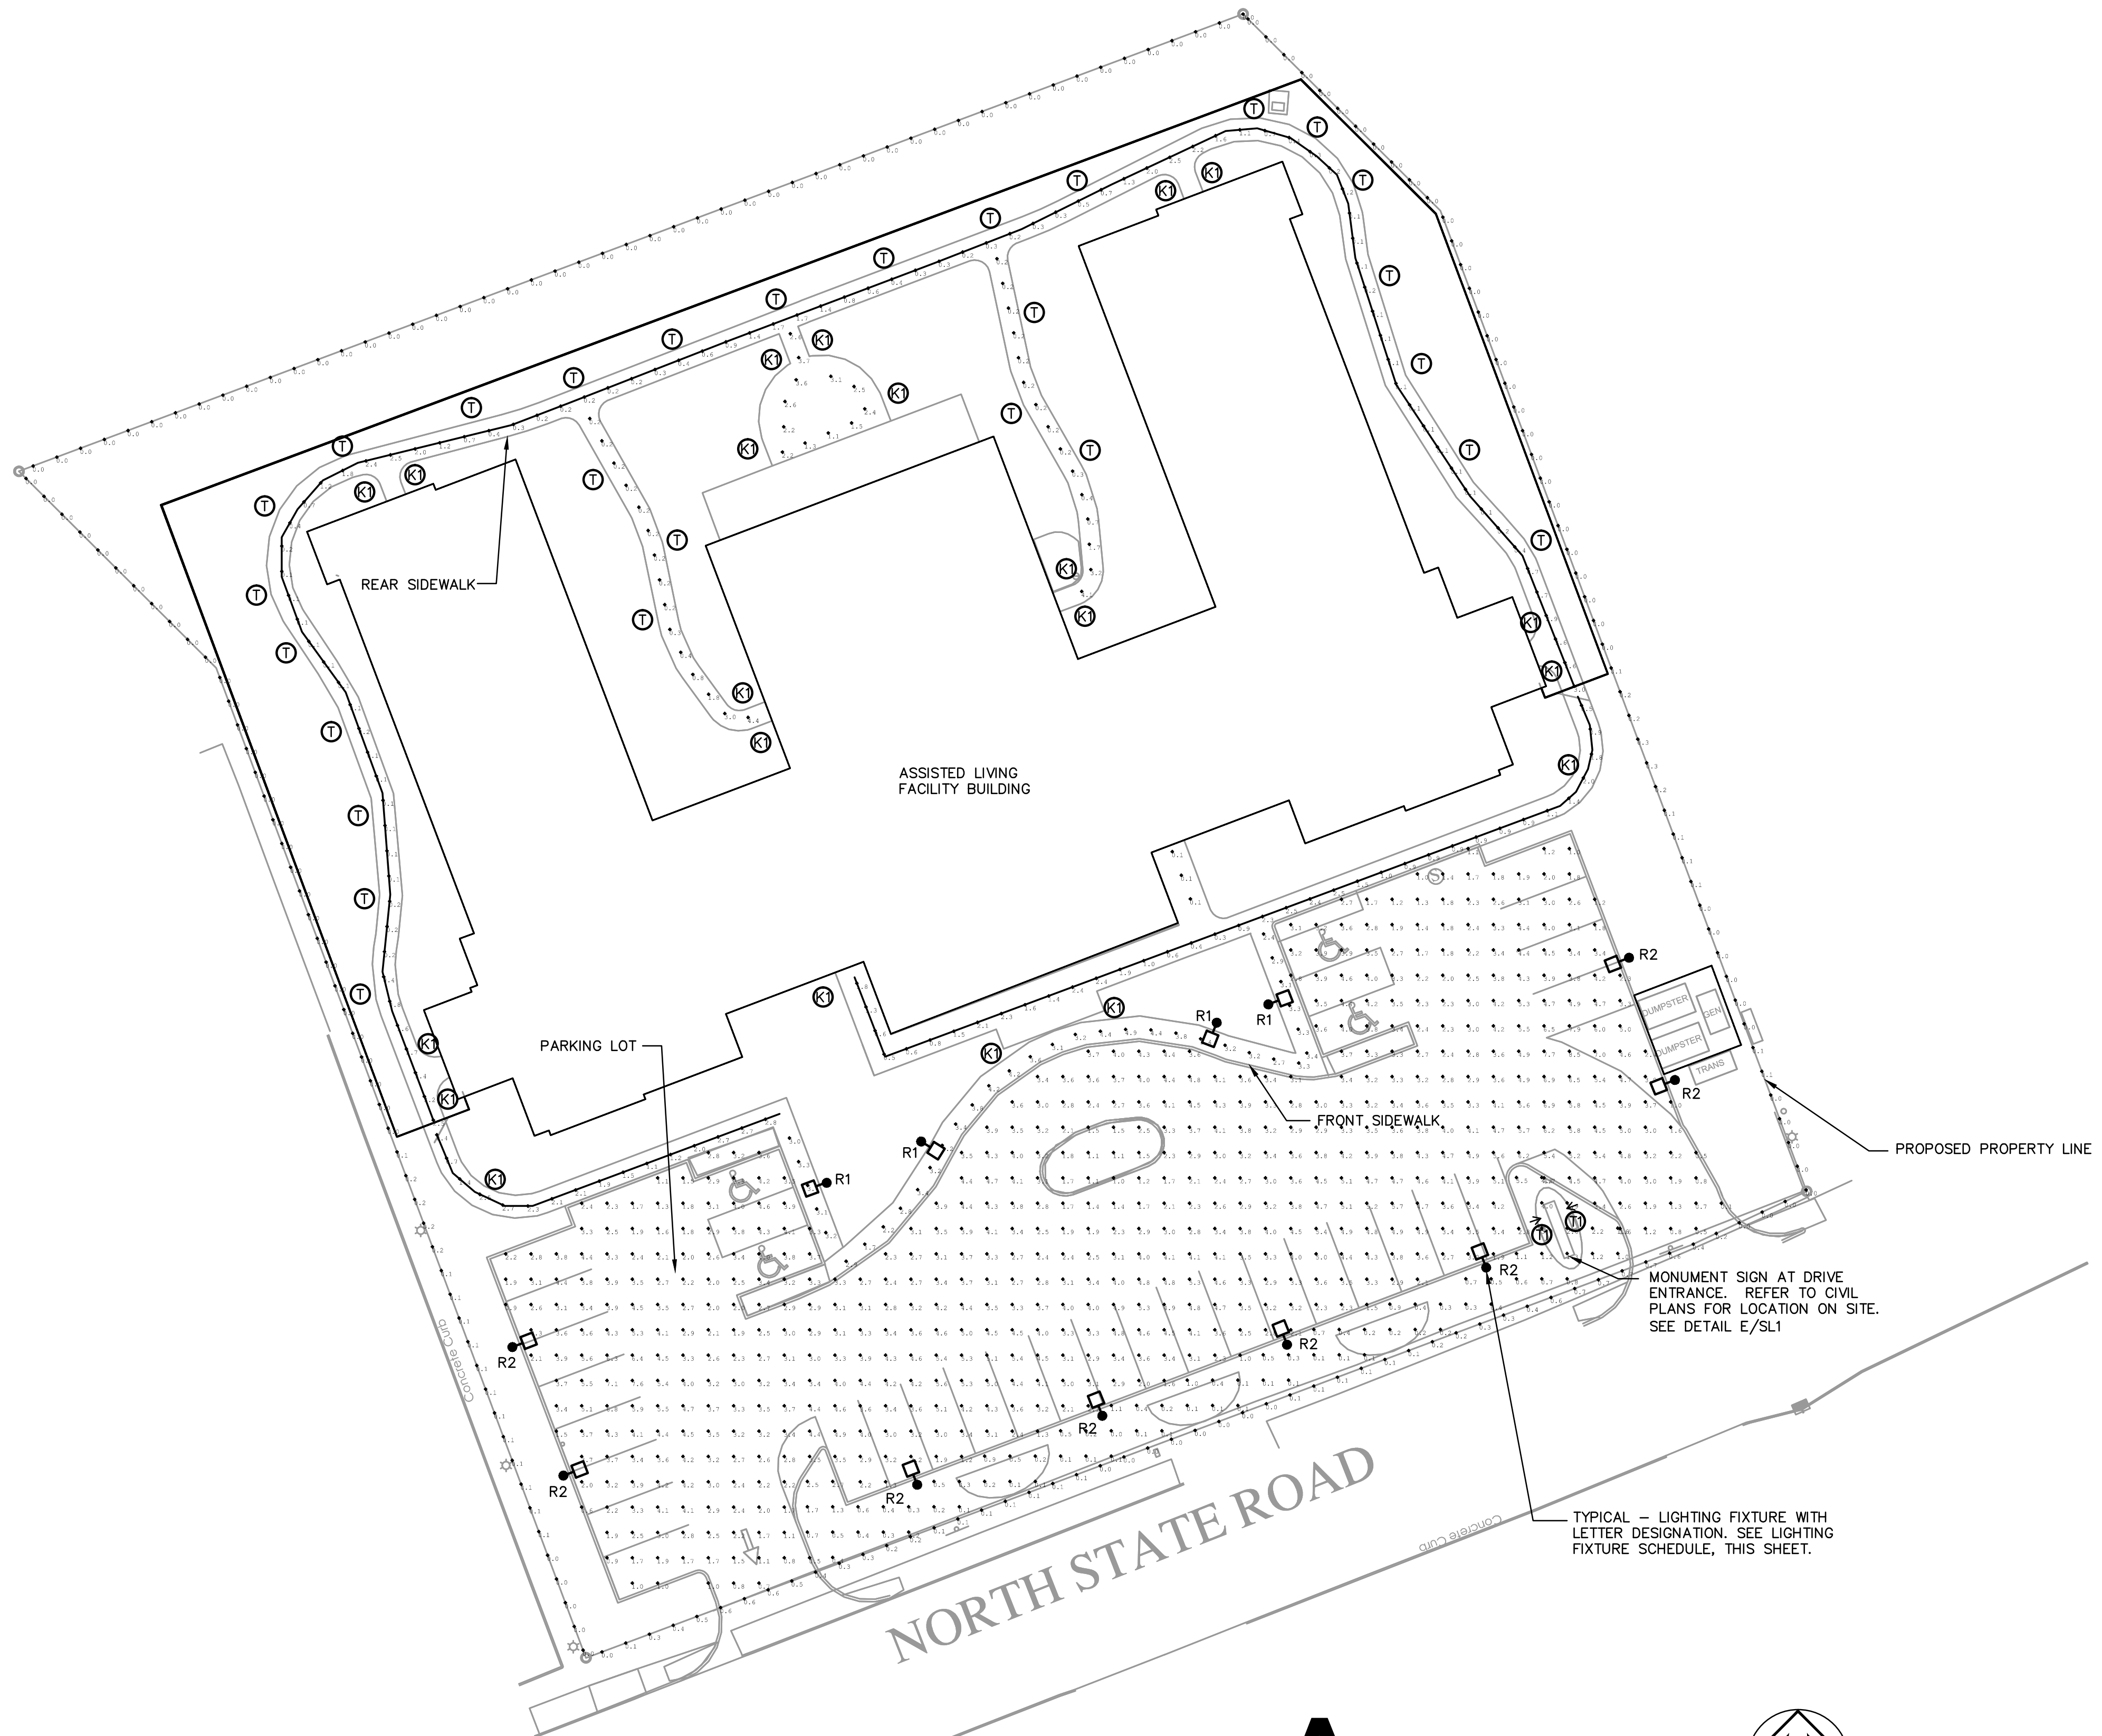

A SITE LIGHTING PLAN

