




JAPANESE FOREST GRASS



SPRINKER BOXWOOD

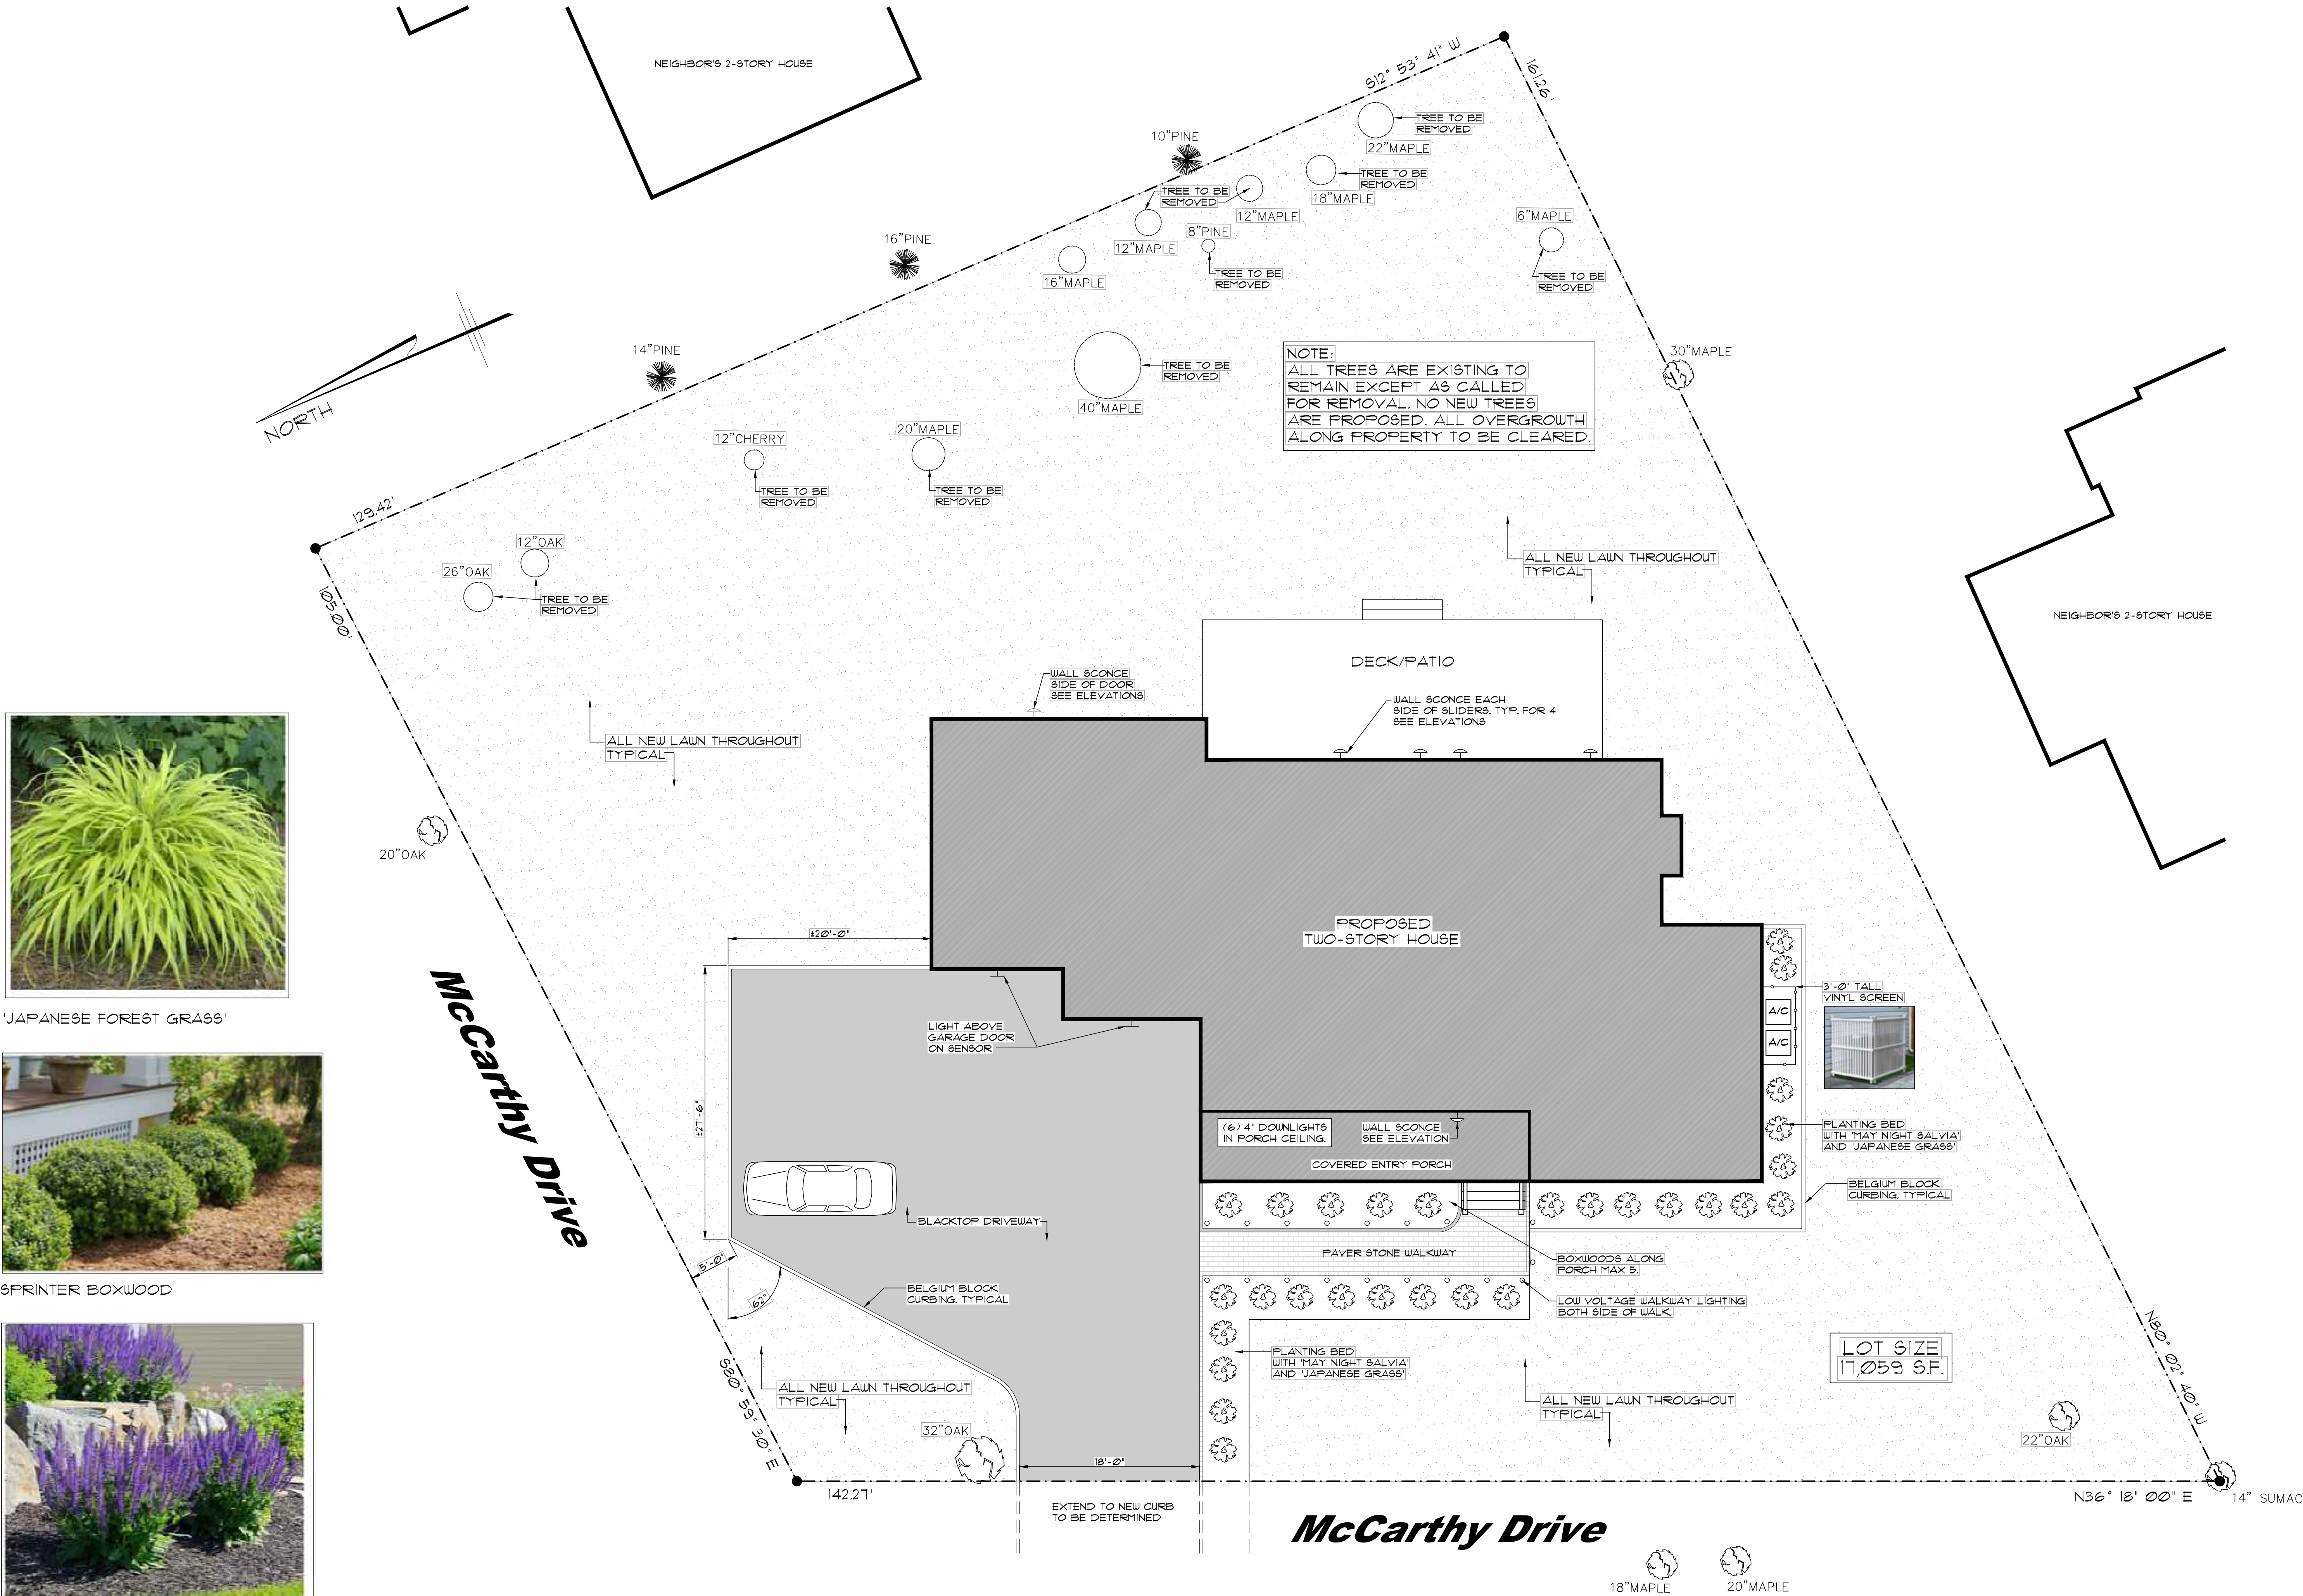

MAY NIGHT SALVIA

PROPOSED PLANTING

SITE LANDSCAPING AND LIGHTING PLAN

SITE INFORMATION TAKEN FROM SURVEY PREPARED BY: JRL LAND SURVEYORS, P.C. MAHOPAC, NEW YORK AND DATED: AUGUST 25, 2020

1/8" = 1'-0"

SIMEOFORIDES
ARCHITECT

William Simeoforides Architect
TWO SOMERSTOWN ROAD
OSSINING, NEW YORK 10562
TEL. 914.260.5487 FAX.914.432.7140
EMAIL. simeoarchitect@optimum.net

NO.	DATE	ISSUE/REVISION
	23 AUG '21	ARB RE-ISSUE
	5 JULY '21	REVISIONS AND ARB ISSUE
	23 APRIL '21	CLIENT SCALED DOWN REVISIONS
	5 MAR '21	CLIENT REVISIONS
	19 FEB '21	CLIENT REVISED/REVIEW ISSUE

CLIENT/LOCATION:
CAPASSO RESIDENCE
34 MCCARTHY DRIVE
OSSINING, NEW YORK

DRAWING:
PROPOSED SITE
LANDSCAPING/LIGHTING PLAN



SCALE:
AS NOTED
DATE:
15 FEB 2021
BY:
W.S.
SK-2