




JAPANESE FOREST GRASS'



SPRINTER BOXWOOD

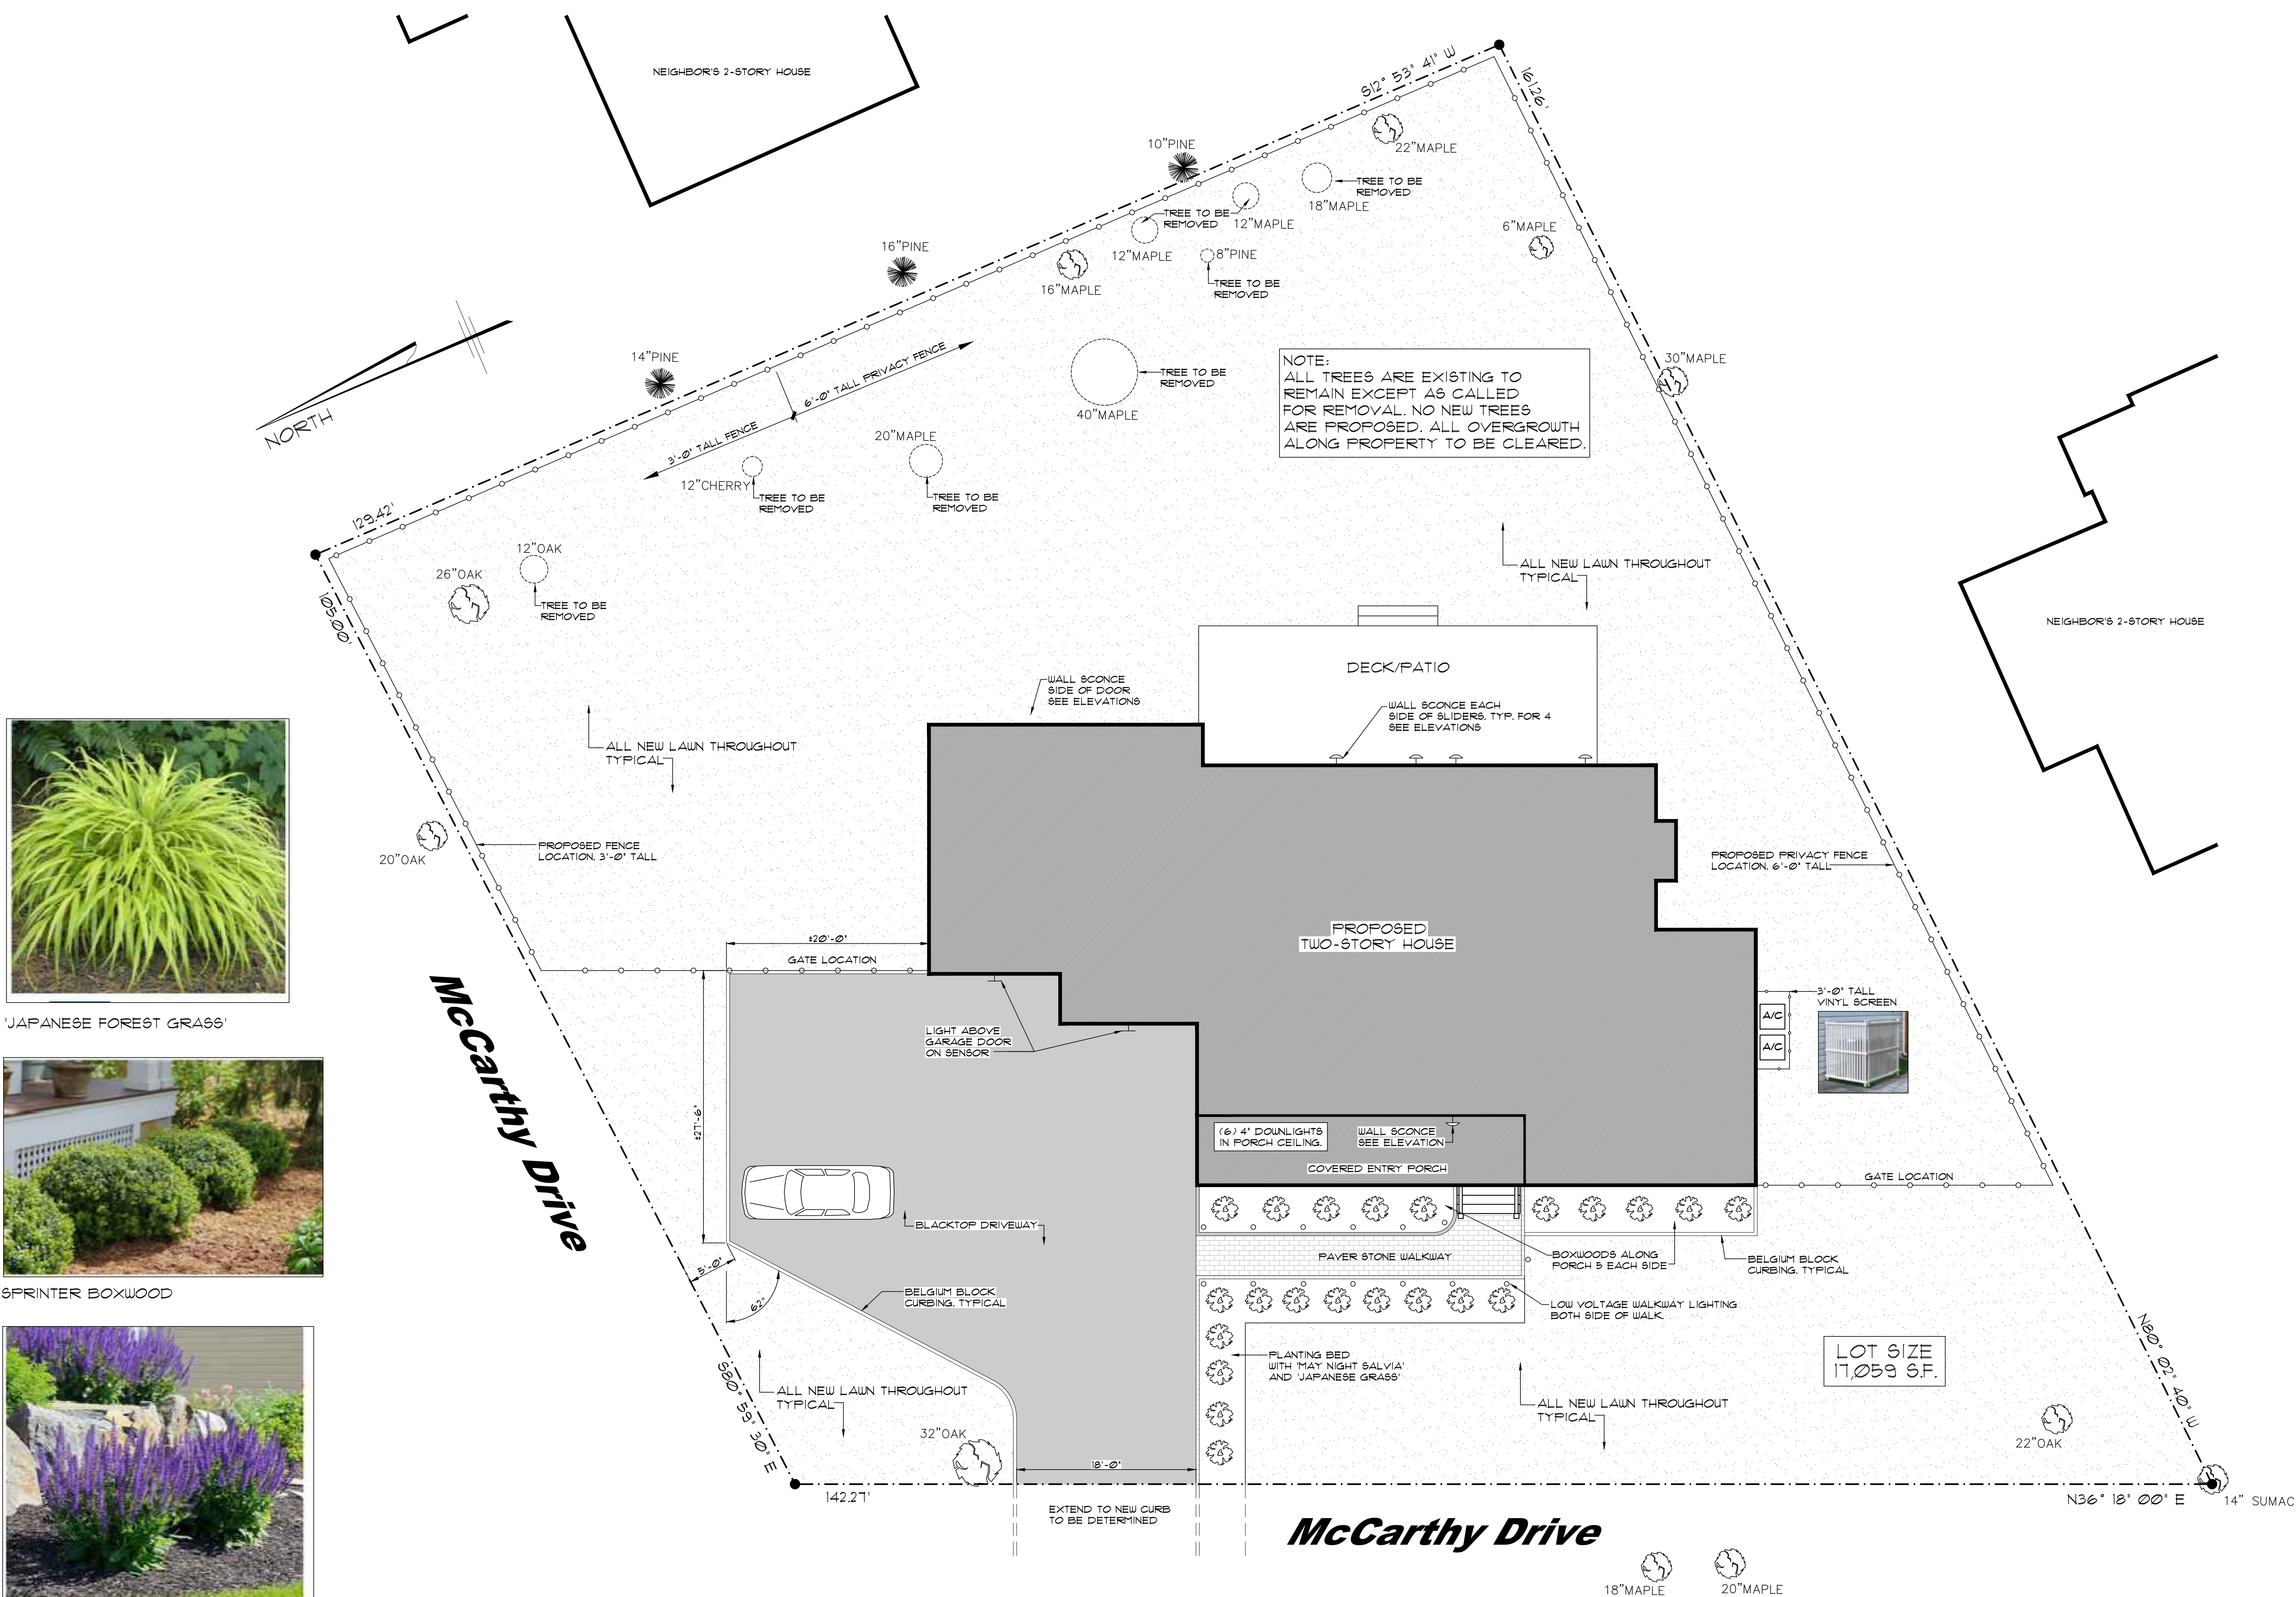


'MAY NIGHT SALVIA'

PROPOSED PLANTING

SITE LANDSCAPING AND LIGHTING PLAN

SITE INFORMATION TAKEN FROM SURVEY PREPARED BY: JRL LAND SURVEYORS, P.C., MAHOPAC, NEW YORK AND DATED: AUGUST 25, 2020

1/8" = 1'-0"

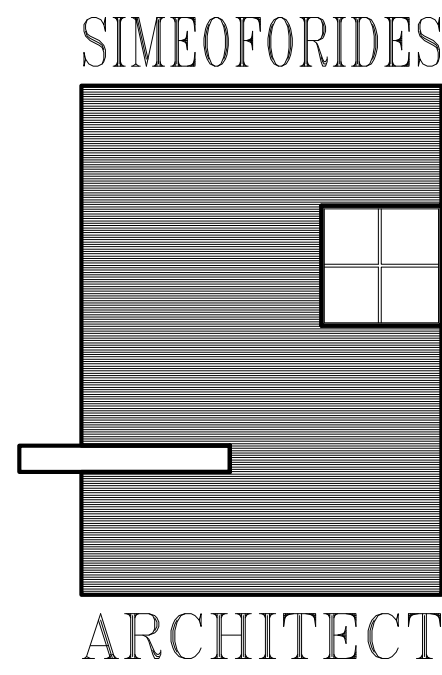

William Simeoforides Architect
TWO SOMERSTOWN ROAD
OSSINING, NEW YORK 10562
TEL. 914.260.5487 FAX.914.432.7140
EMAIL. simeoarchitect@optimum.net

NO.	DATE	ISSUE/REVISION
17 SEPT. '21		ARB RE-ISSUE
23 AUG '21		ARB RE-ISSUE
5 JULY '21		REVISIONS AND ARB ISSUE
23 APRIL '21		CLIENT SCALED DOWN REVISIONS
5 MAR '21		CLIENT REVISIONS
19 FEB '21		CLIENT REVISED/REVIEW ISSUE

CLIENT/LOCATION:
CAPASSO RESIDENCE
34 McCarthy Drive
OSSINING, NEW YORK

DRAWING:
PROPOSED SITE
LANDSCAPING/LIGHTING PLAN

SCALE:
AS NOTED
DATE:
15 FEB 2021
BY:
W.S.

SK-2