 


[illegible]

ARTIS SENIOR LIVING
OF BRIARCLIFF
BRIARCLIFF MANOR, NY



Dennis D. Smith, AIA Architect

Dennis D. Smith, AIA Architect ©
345 Riverview Wichita, KS 67203
T 316.268.0230 F 316.268.0205

CONTACT: DAN DOKKEN

DRAWN: SM, JW CHECKED: SB

PROJECT NUMBER:


PROJECT NUMBER:
14690

SHEET TITLE:
SITE LIGHTING PLAN


SHEET NUMBER:
SL1.1

STATISTICS					
DESCRIPTION	AVERAGE	MAXIMUM	MINIMUM	MAX/MIN	AVG/MIN
PARKING LOT	3.12 FC	7.7 FC	0.5 FC	15.4	6.24
PROPERTY LINE	1.12 FC	1.5 FC	0.0 FC	N/A	N/A
FRONT SIDEWALK	1.94 FC	6.3 FC	0.1 FC	9.33	5.03
REAR SIDEWALK	1.53 FC	11.2 FC	0.2 FC	N/A	N/A


FIXTURE TYPE(S)						
SYMBOL	MFR	CATALOG NUMBER	LAMP	LUMENS	LLF	MTG HEIGHT
R1	SPAULDING	CL1-A-30L-U-4K-3-BZ-BC	LED	5132	.9	14"-0" POLE
R2	SPAULDING	CL1-A-30L-U-4K-4-BZ-BC	LED	6318	.9	14"-0" POLE
K1	PROGRESS	PBOL3-AC-12NB-25-3K	LED	1116	.9	42"AFG
T	HYDREL	M4534-18TR1-4-BZ	CF18DD/E/827	2040	.69	5"AFG
T1	STONCO	LPF2-E-4K-FL-K-F1-8-BZ	LED	3460	.69	AT GRADE PEDISTAL

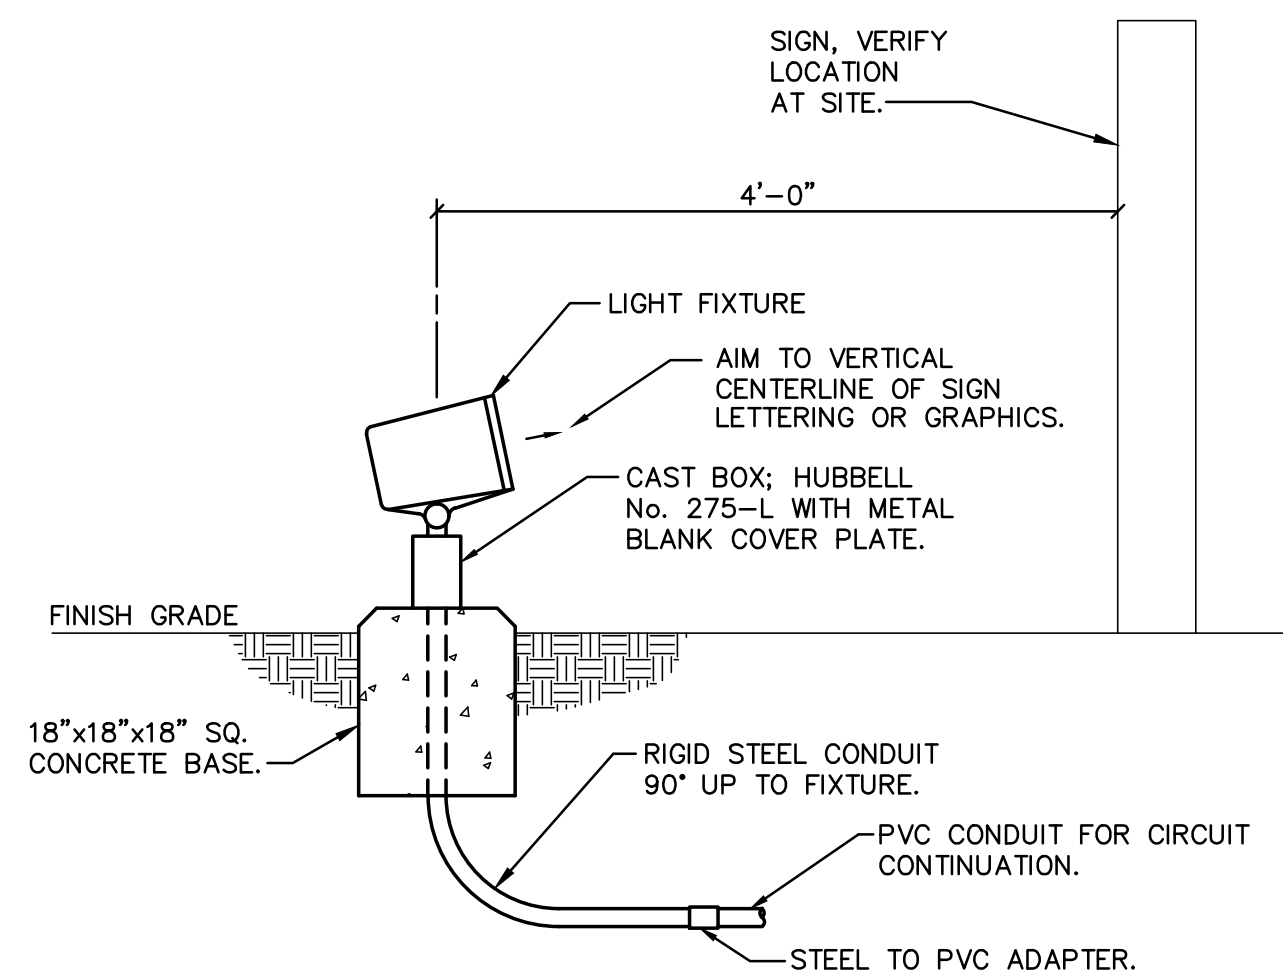

E **FIXTURE TYPE 'T1'**
MOUNTING DETAIL
N.T.S.

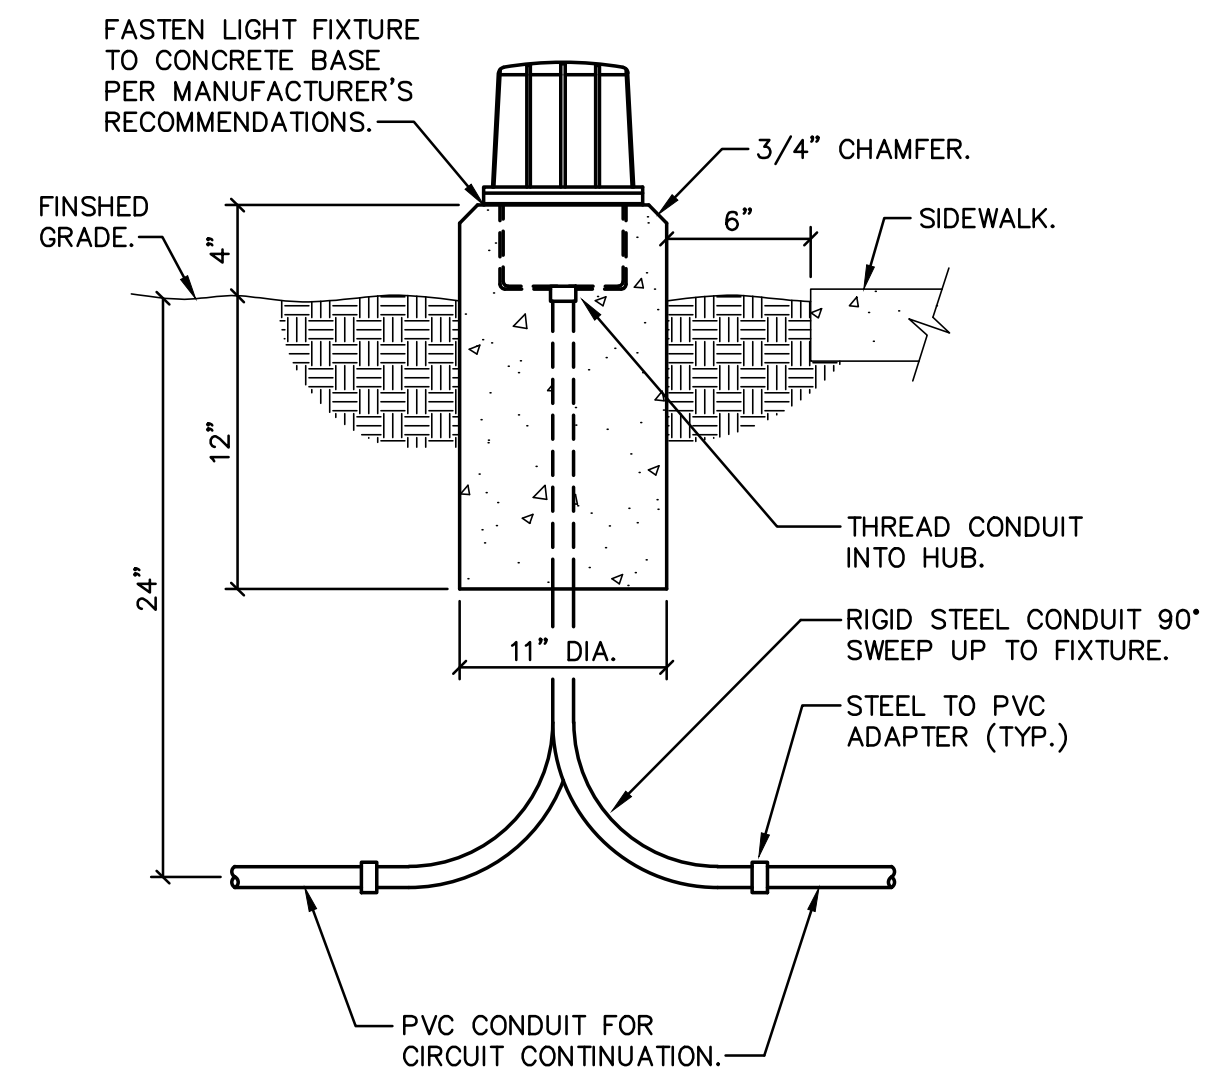


D FIXTURE TYPE 'T' MOUNTING DETAIL

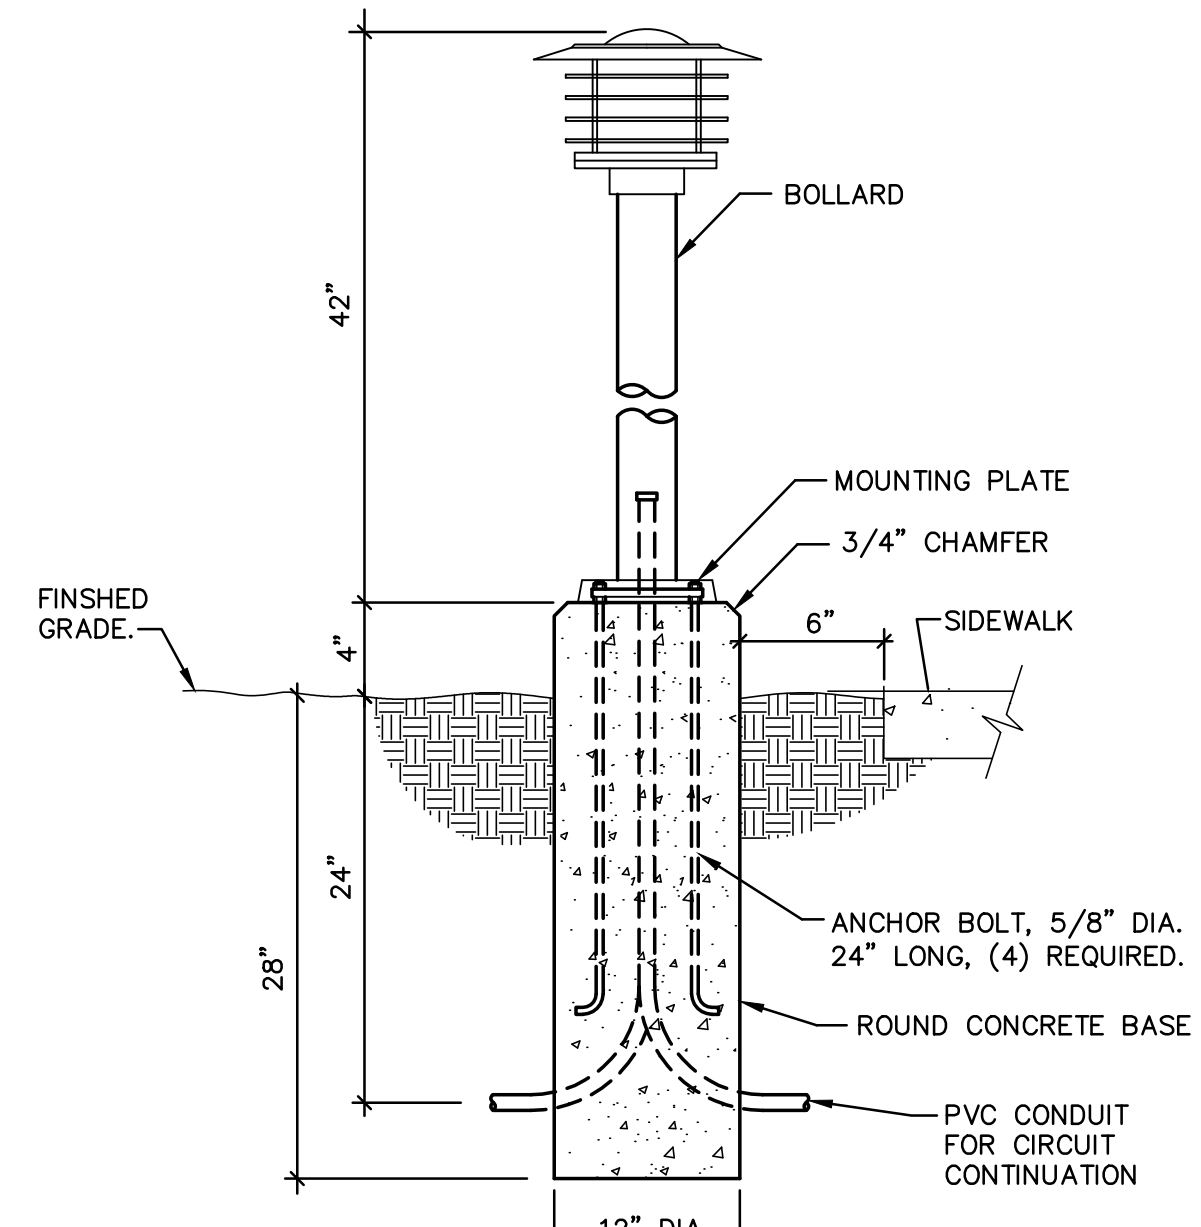

C FIXTURE TYPE 'K1'
MOUNTING DETAIL
N.T.S.


The color temperature of all site lighting fixtures shall be 3,000k or less

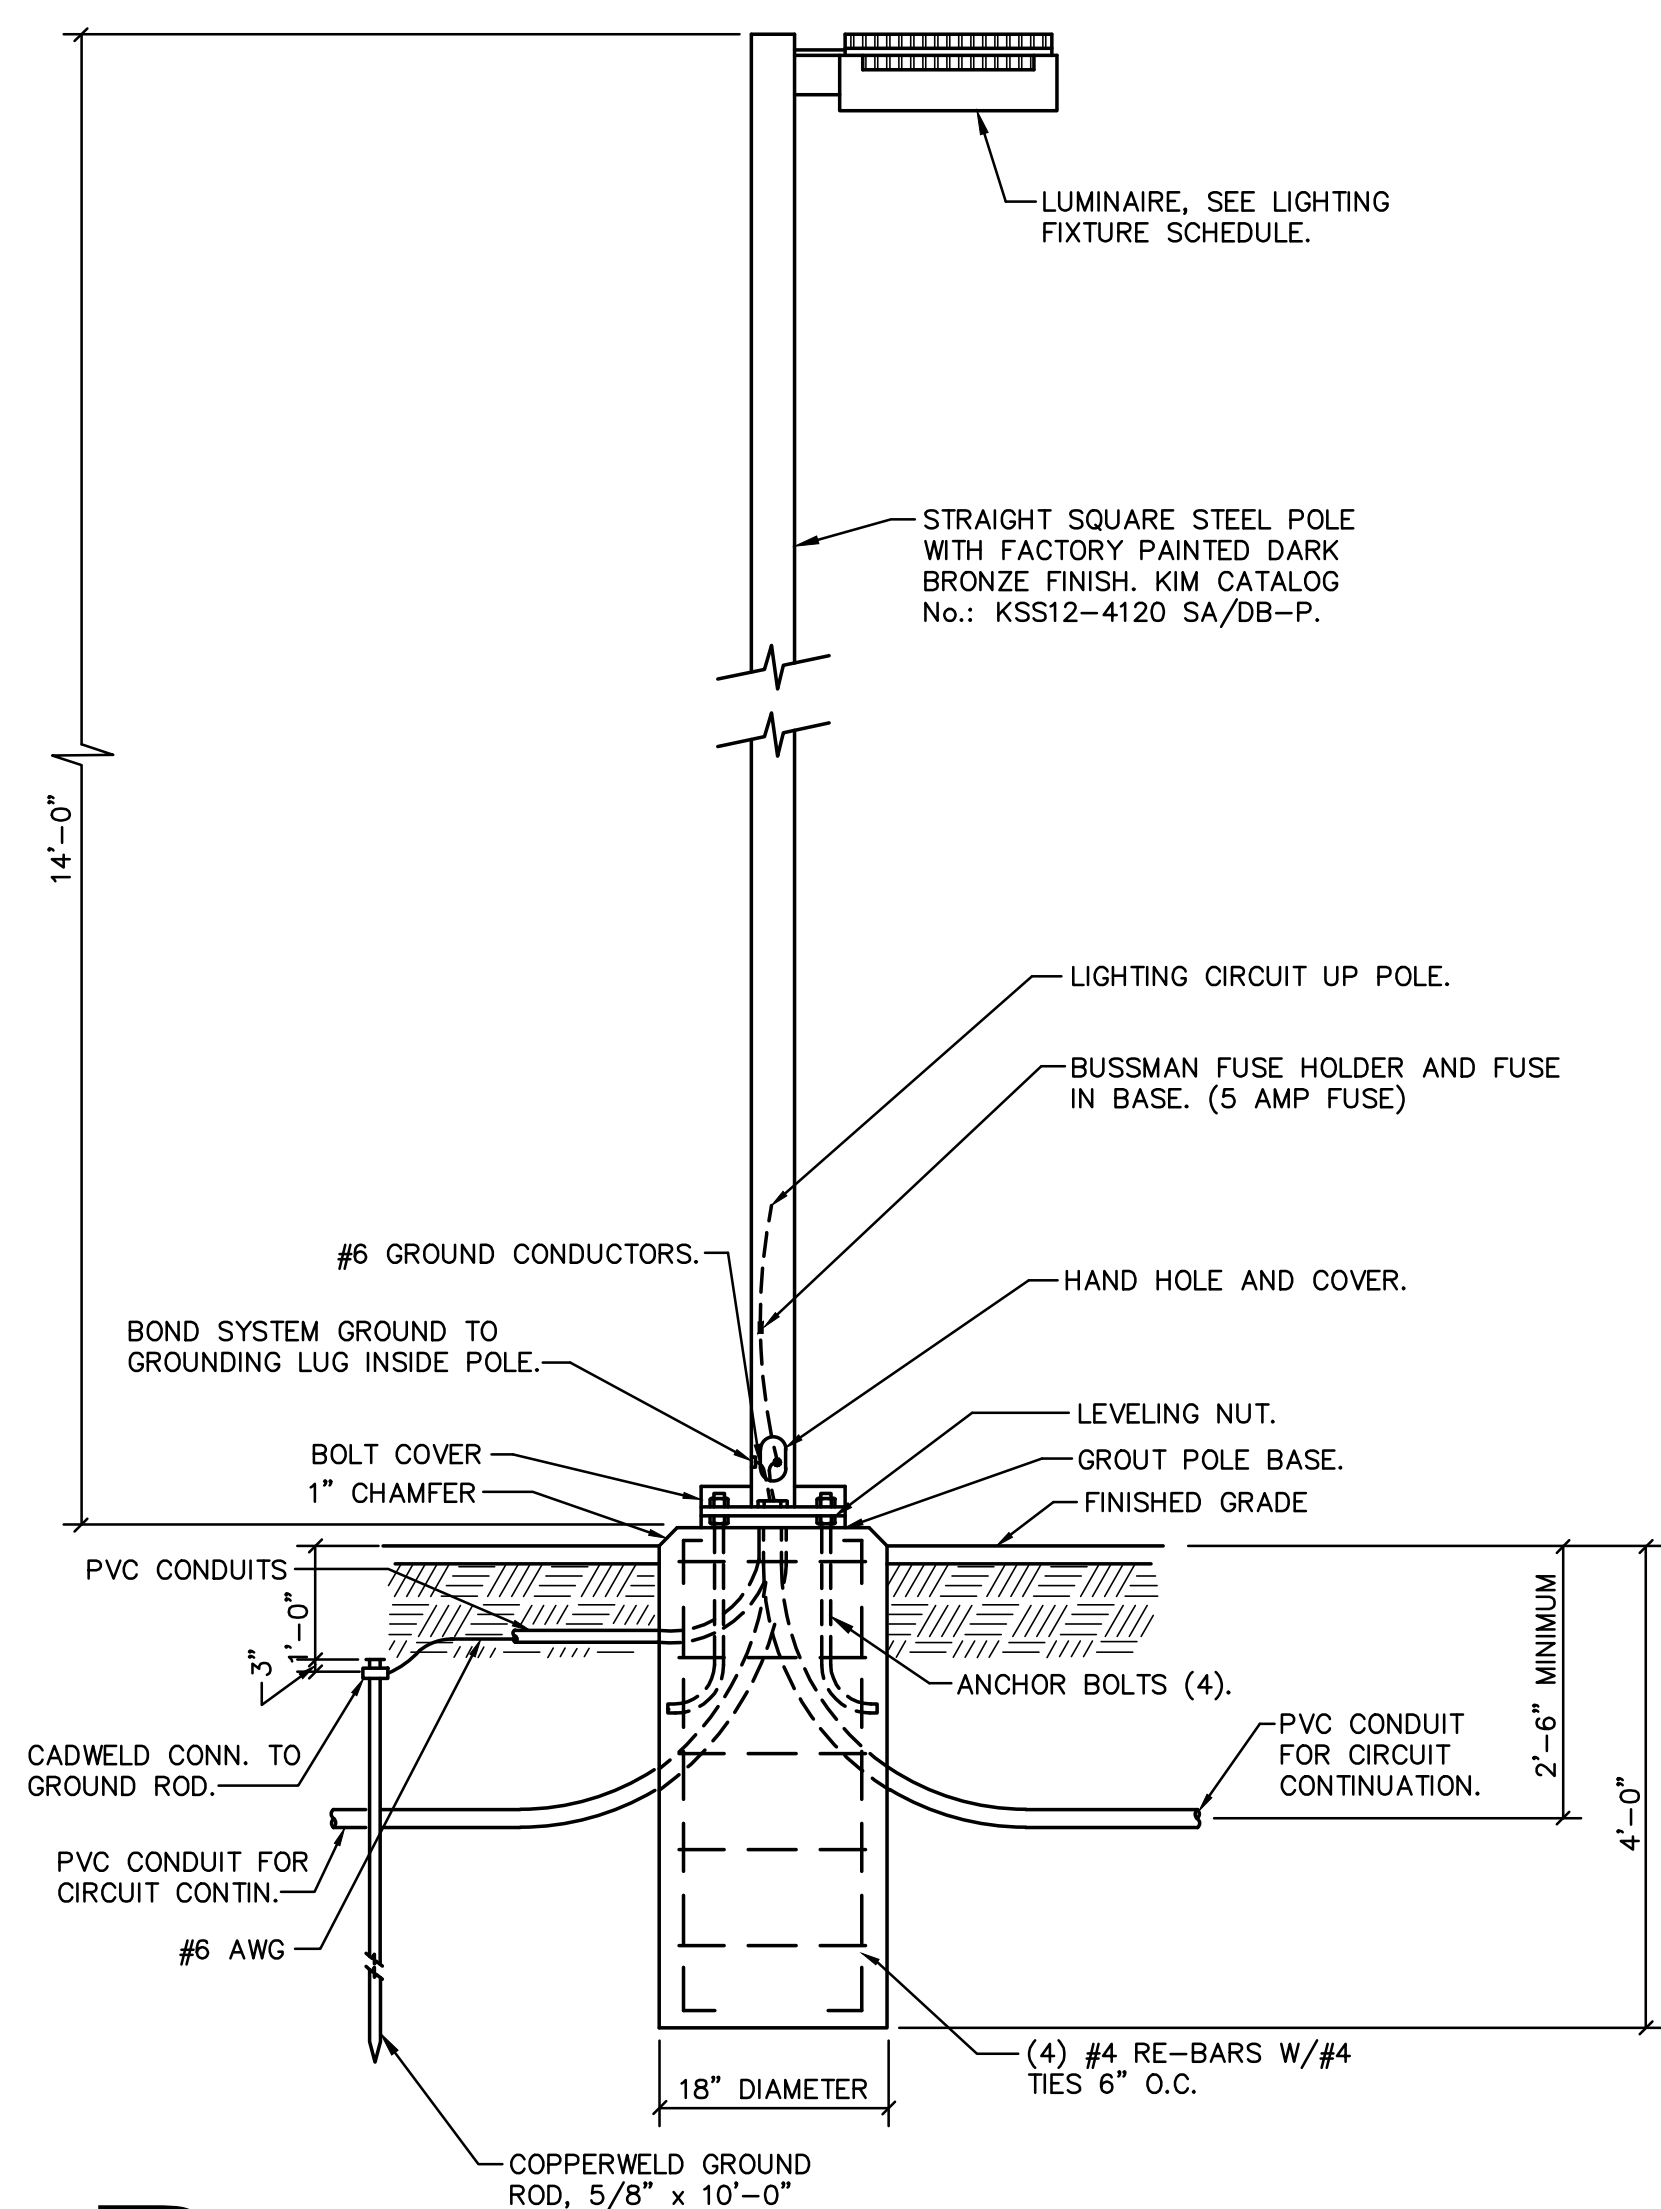

ROD, 5/8" x 10'-0"

B **FIXTURE TYPE 'R1' & 'R2' MOUNTING DETAIL**

N.T.S.

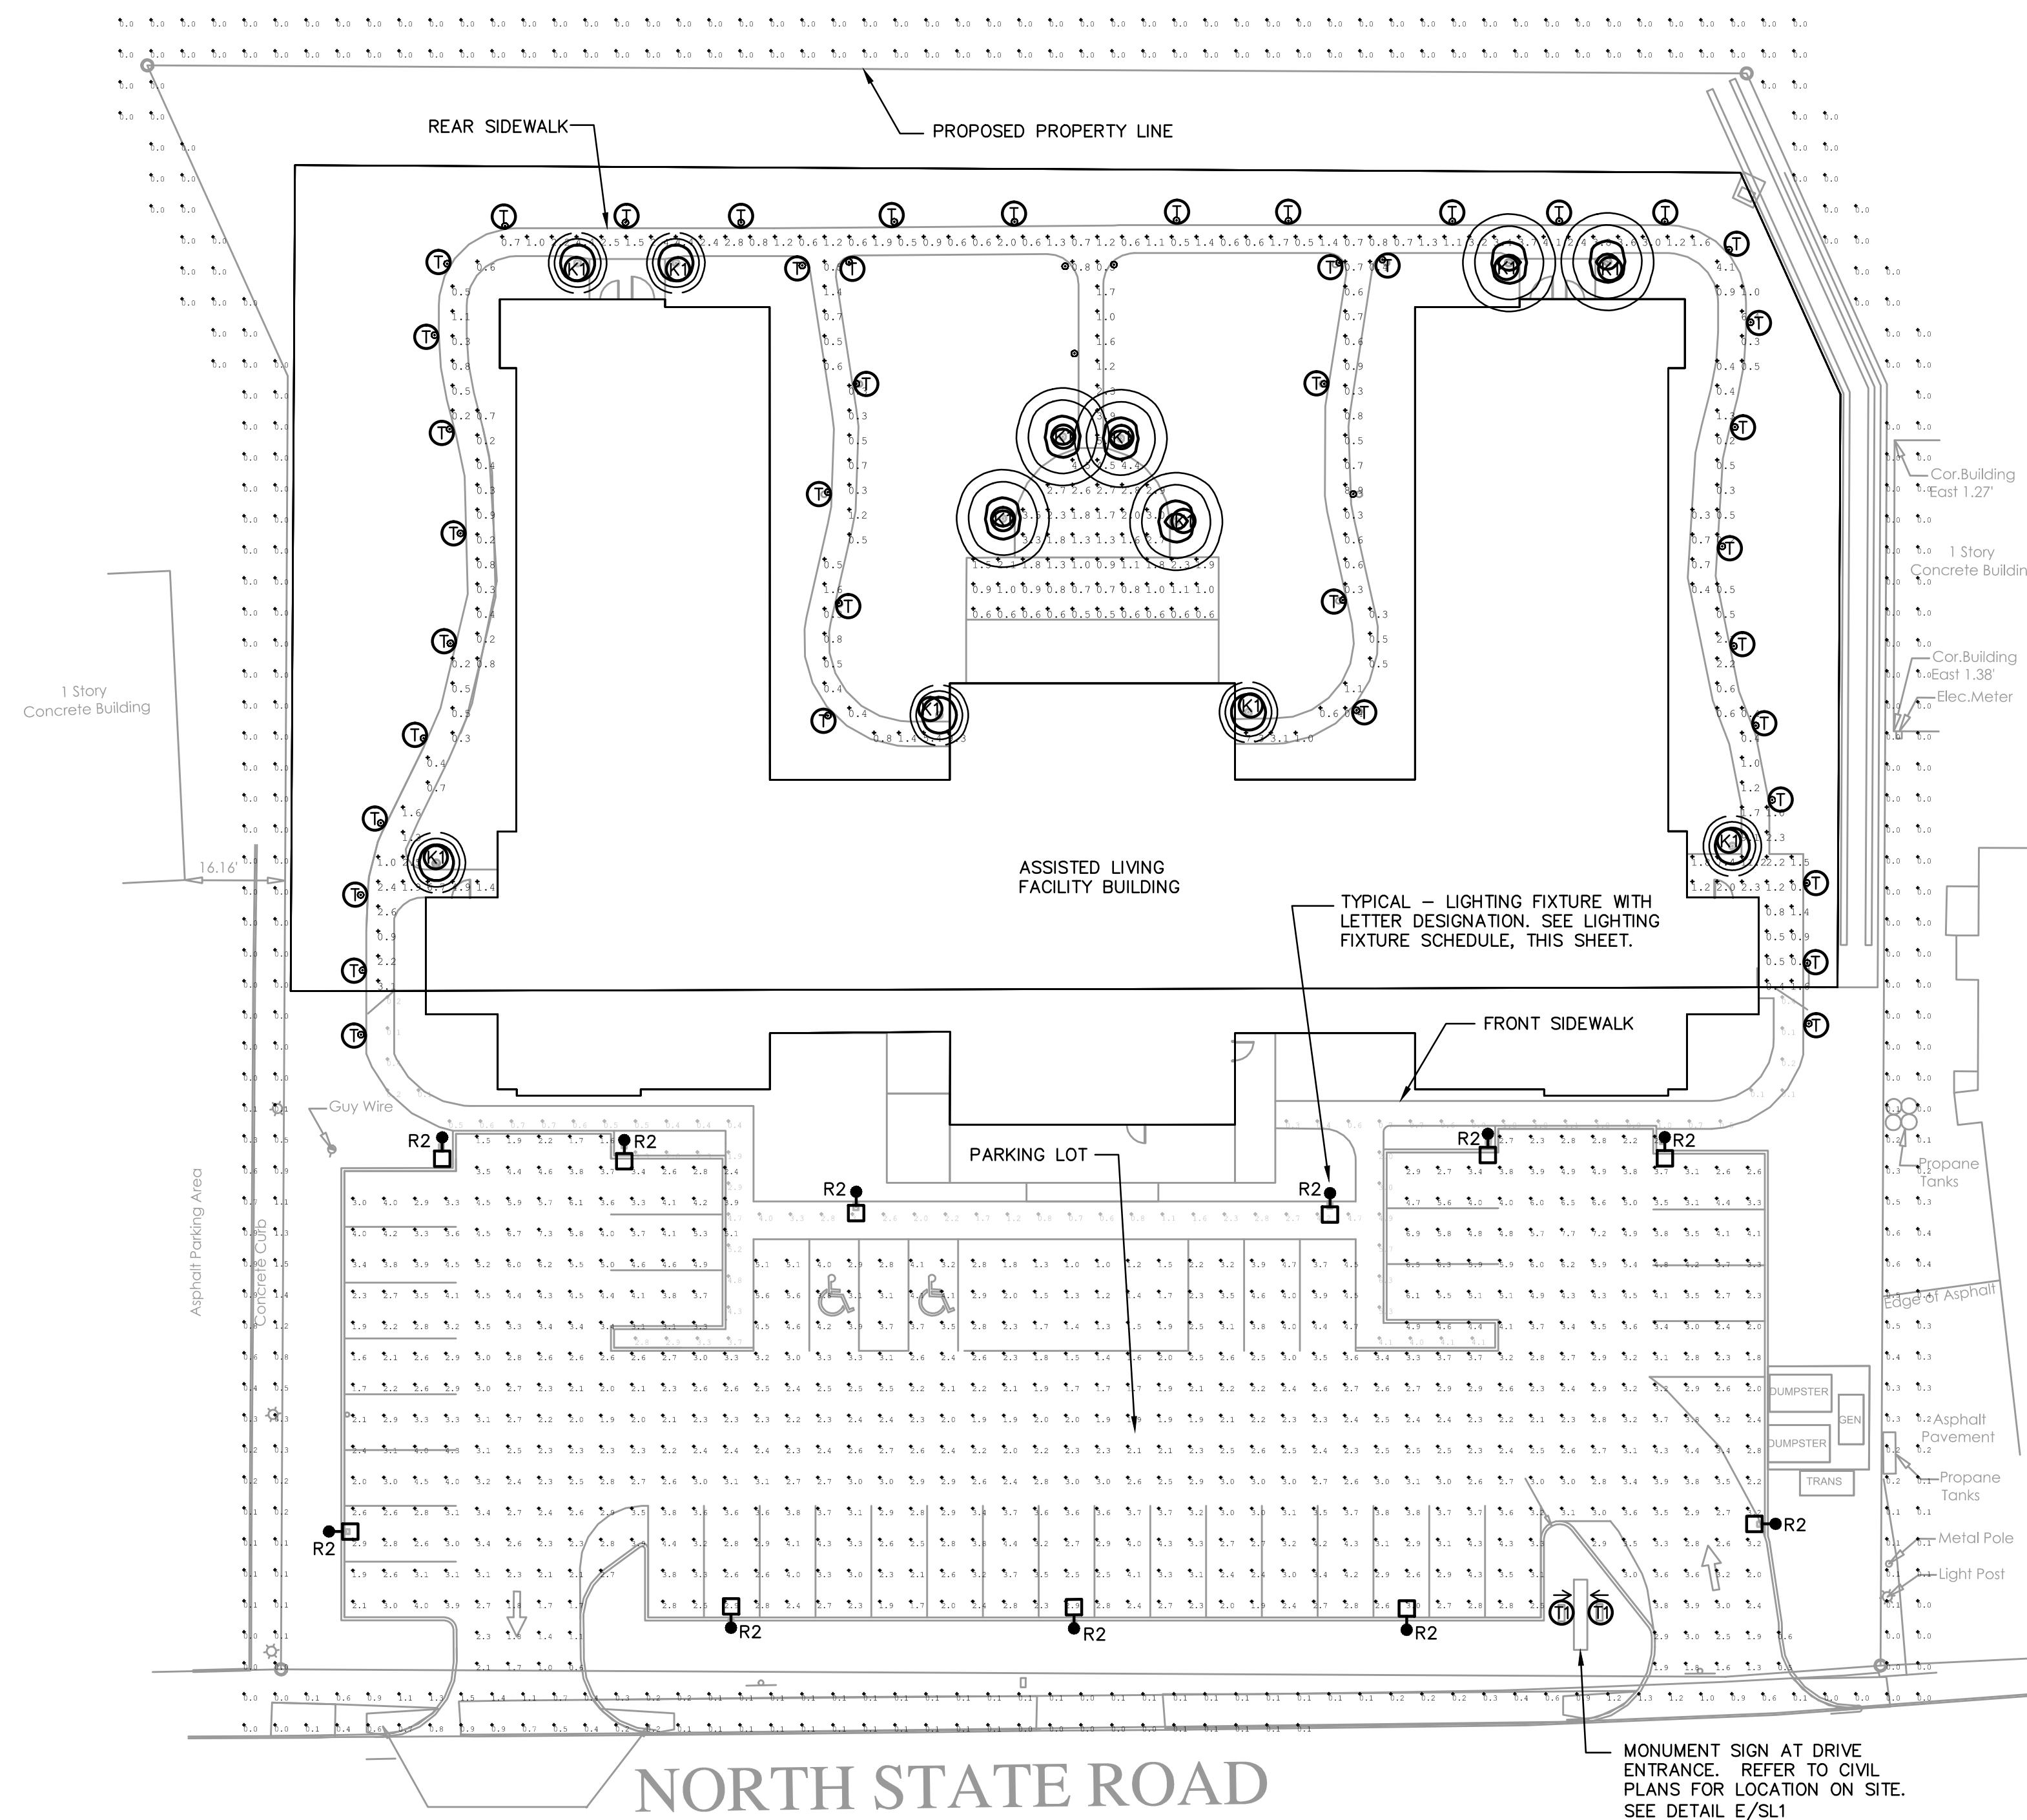

A SITE LIGHTING PLAN

